




ISOMETRIC VIEW

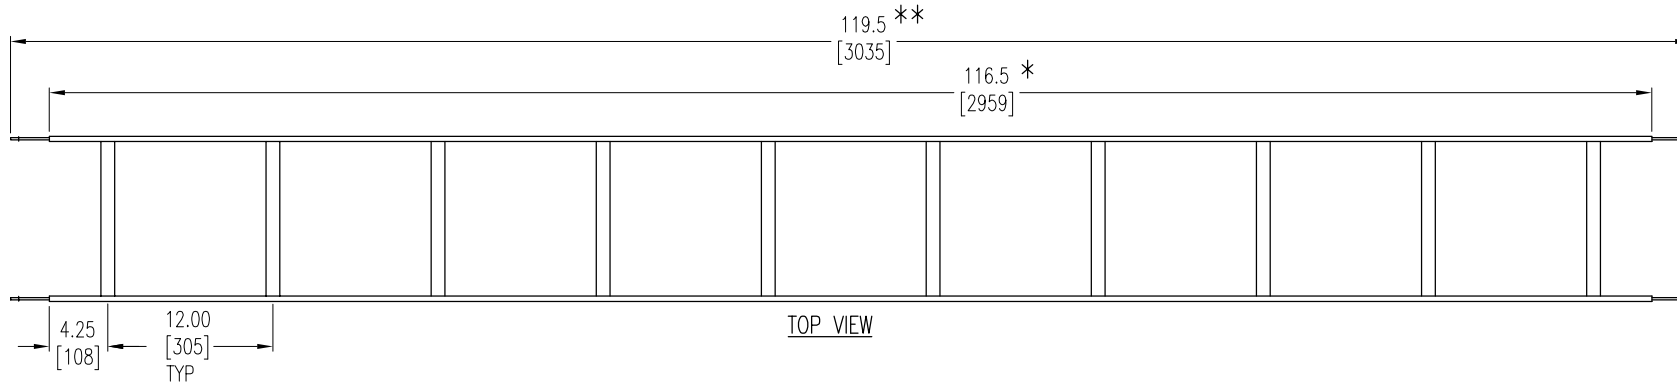


TOP VIEW

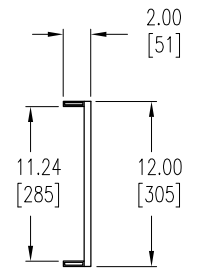


SIDE VIEW

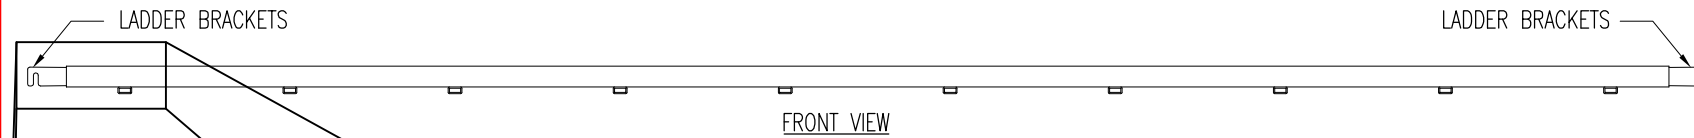

FRONT VIEW

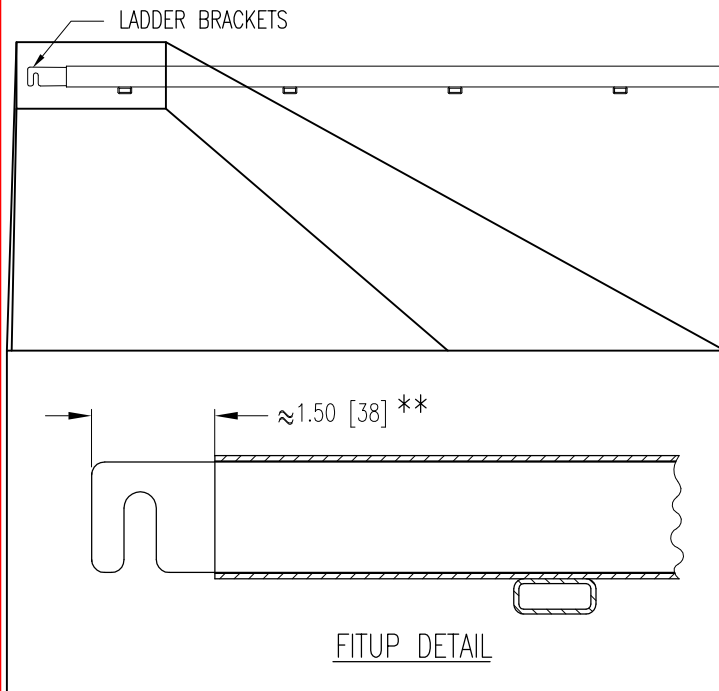

FITUP DETAIL

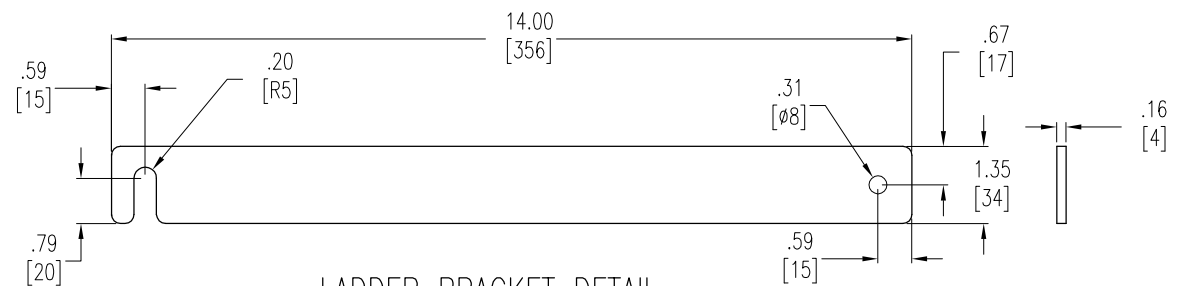

LADDER BRACKET DETAIL

NOTES:

ALL DIMENSIONS ARE IN INCHES [MILLIMETERS].

\* MANUFACTURED LENGTH; FINAL LENGTH IS CUT TO ORDER.

\*\* THESE DIMENSIONS MAY VARY.

THIS DRAWING AND SPECIFICATIONS HEREIN ARE THE PROPERTY OF AMERICAN POWER CONVERSION AND SHALL NOT BE COPIED, REPRODUCED OR USED IN WHOLE OR IN PART, AS THE BASIS FOR THE MANUFACTURE OR SALE OF ITEMS WITHOUT WRITTEN PERMISSION FROM APC. THIS DRAWING IS BASED UPON LATEST AVAILABLE INFORMATION AND IS SUBJECT TO CHANGE WITHOUT NOTICE.

TITLE: InfraStruXure  
CABLE SUPPORT LADDER-12"  
MECHANICAL DETAILS  
PROJECT: SUBMITTAL DRAWINGS SHEET 1 OF 1

DWG NO: AR8165ABLK  
REV: 5  
DRAWN BY: M.CRAVEN  
CHECKED BY: B.SHERIDAN/ F.DIOSA  
ENGINEER: R.HANSEN/ E.SILVA  
08/08/05  
08/08/05  
08/08/05

**APC**  
AMERICAN POWER CONVERSION  
132 FAIRGROUNDS RD  
WEST KINGSTON, RI 02892